



The Office of the Future Available Today !

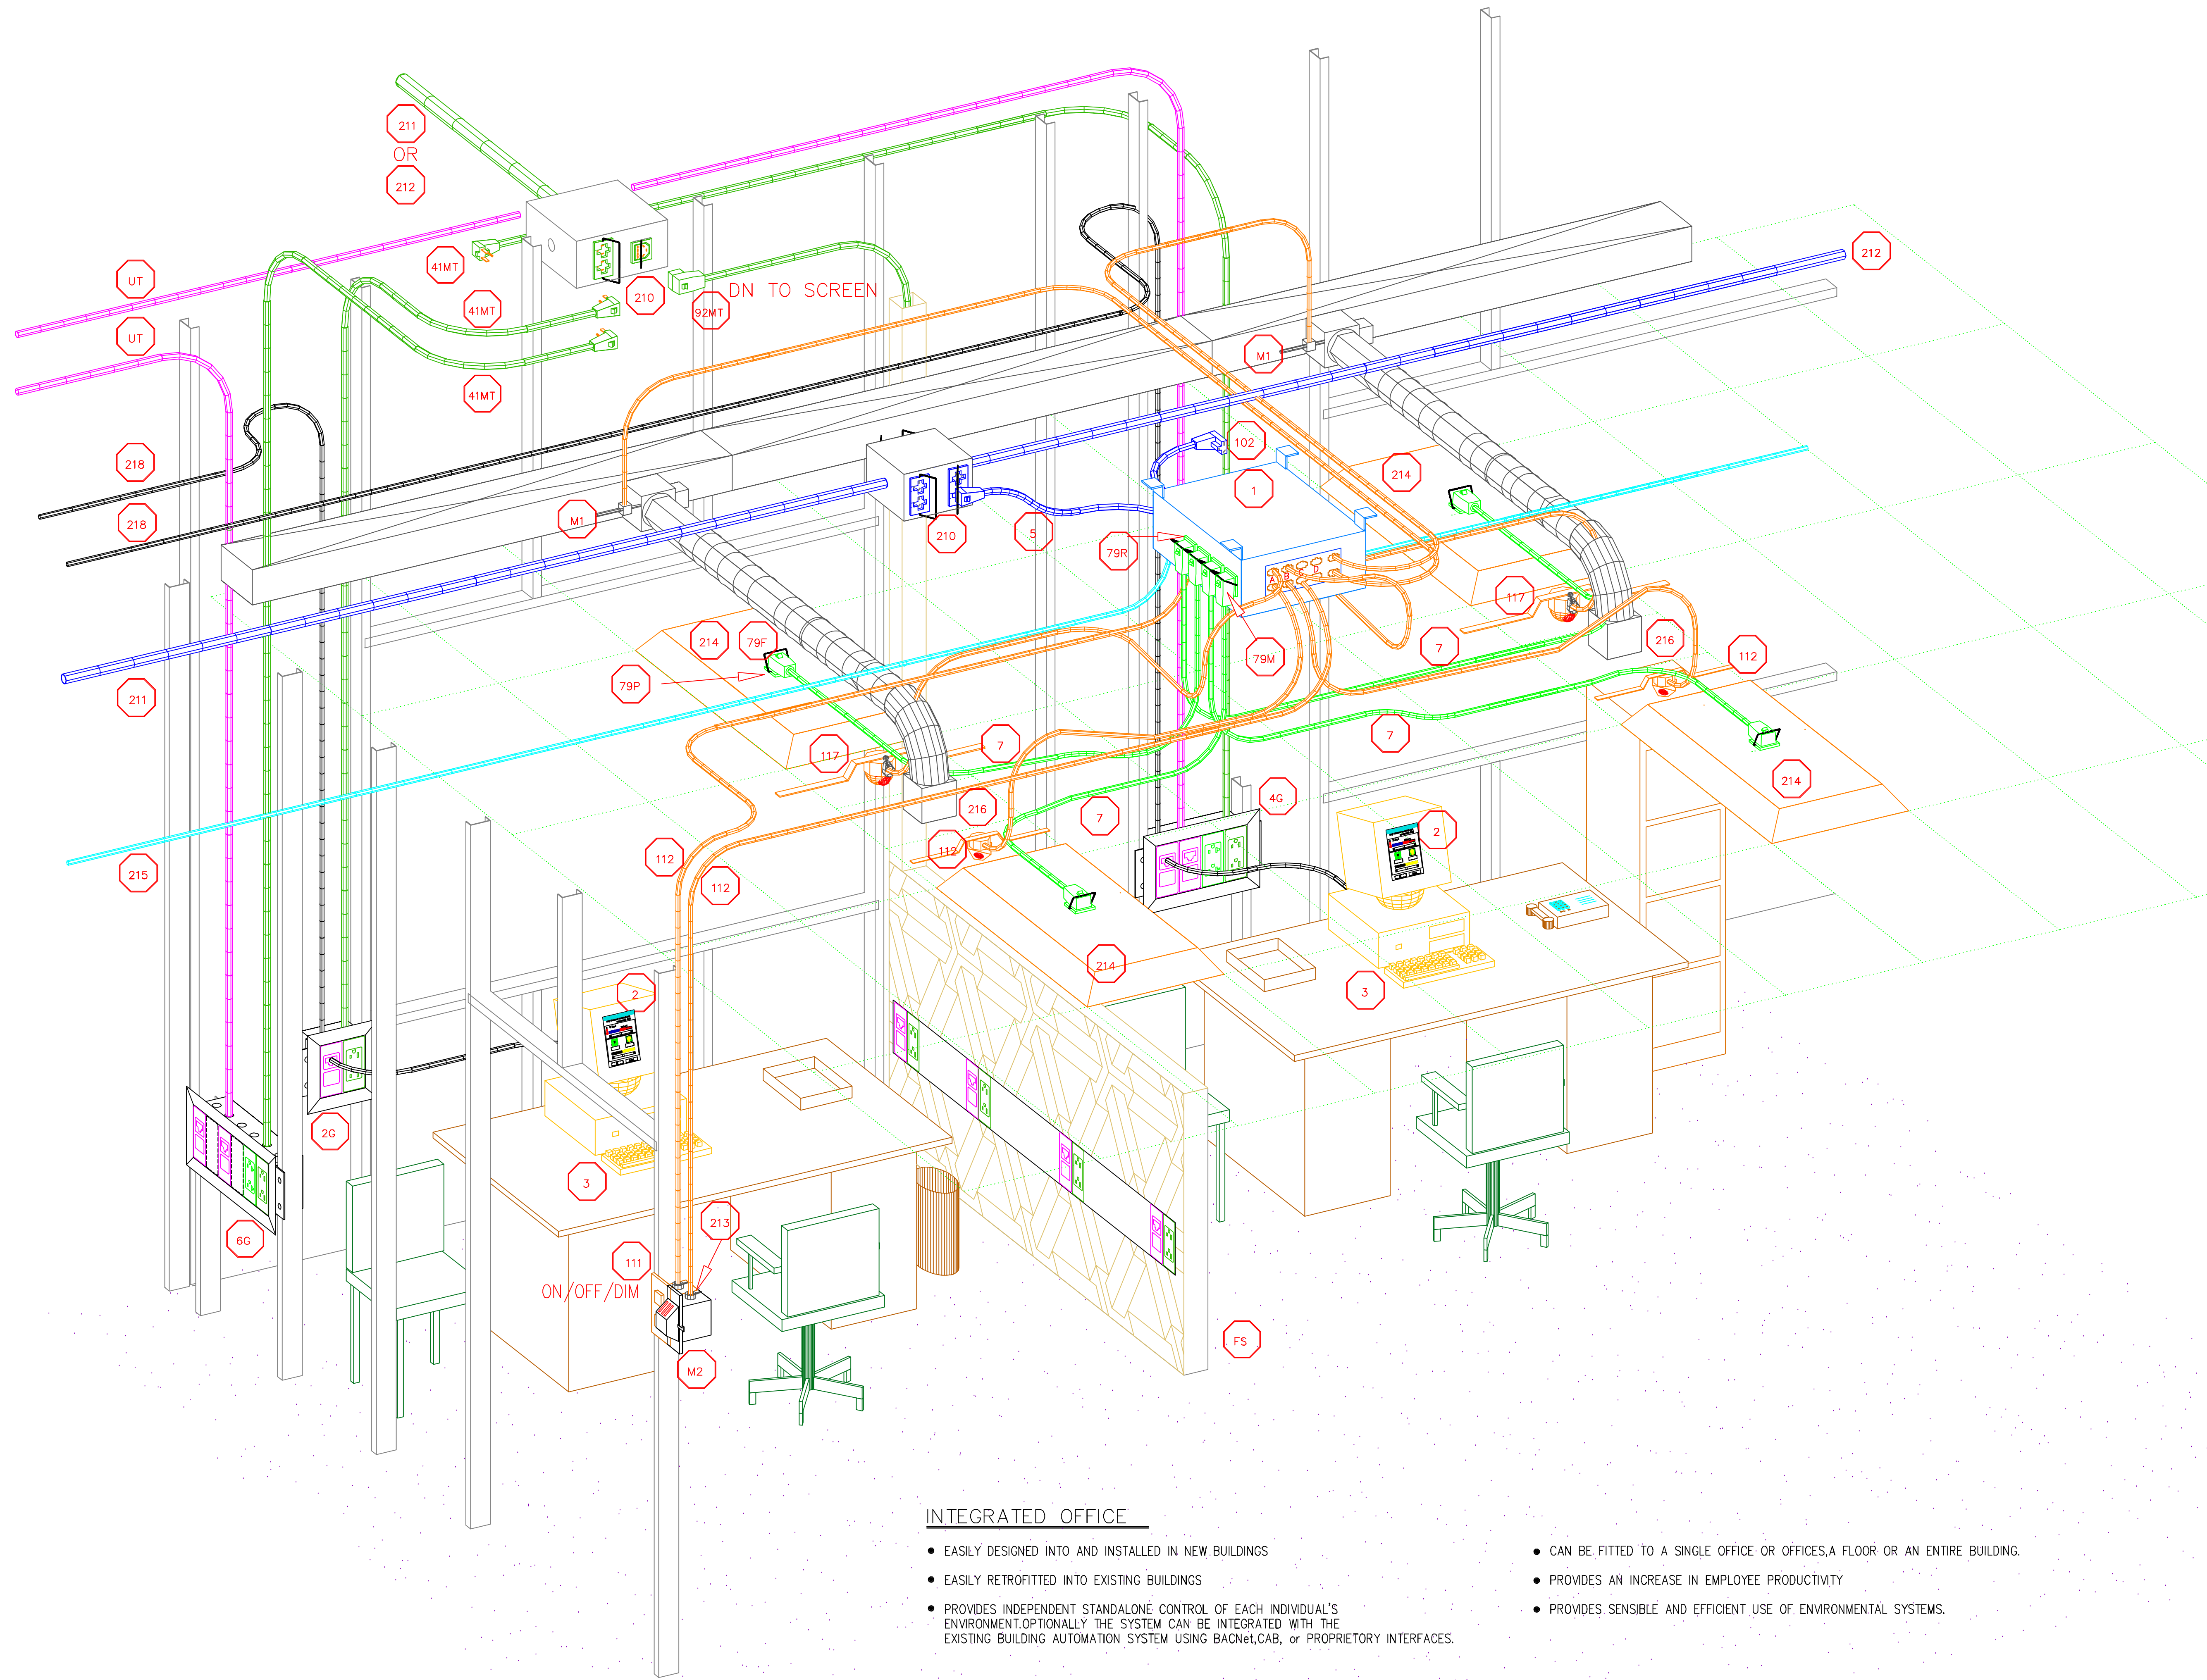


INTEGRATED OFFICE


- EASILY DESIGNED INTO AND INSTALLED IN NEW BUILDINGS
- EASILY RETROFITTED INTO EXISTING BUILDINGS
- PROVIDES INDEPENDENT STANDALONE CONTROL OF EACH INDIVIDUAL'S ENVIRONMENT. OPTIONALLY THE SYSTEM CAN BE INTEGRATED WITH THE EXISTING BUILDING AUTOMATION SYSTEM USING BACnet, CAB, or PROPRIETARY INTERFACES.
- CAN BE FITTED TO A SINGLE OFFICE OR OFFICES, A FLOOR OR AN ENTIRE BUILDING.
- PROVIDES AN INCREASE IN EMPLOYEE PRODUCTIVITY
- PROVIDES SENSIBLE AND EFFICIENT USE OF ENVIRONMENTAL SYSTEMS.

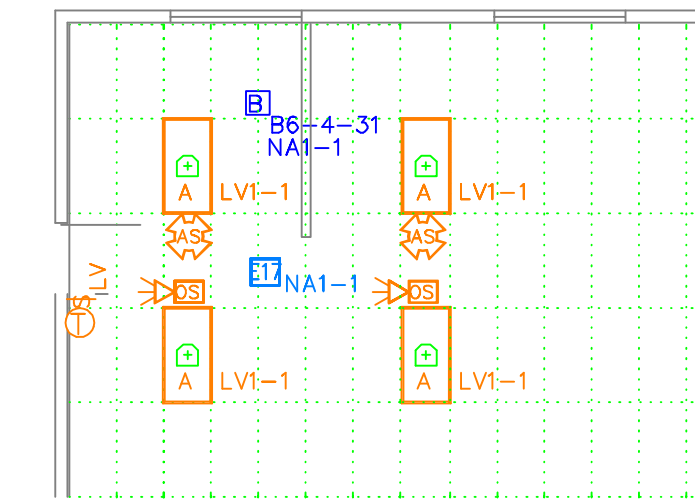

FLOOR PLAN
N.T.S.

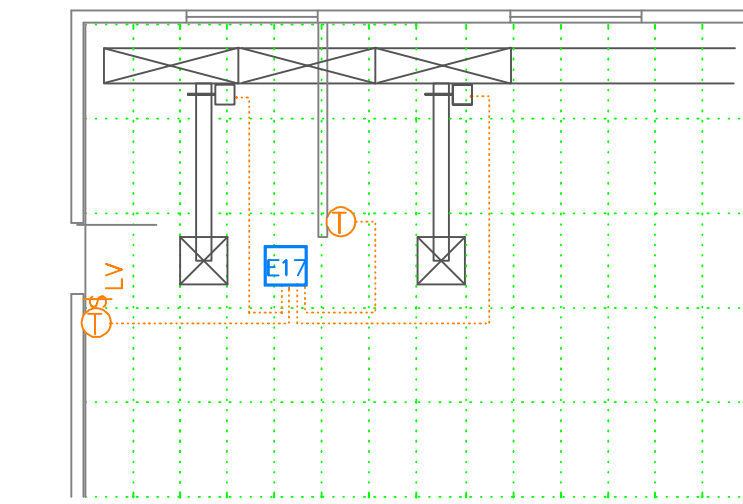

VENTILATION FLOOR PLAN
N.T.S.

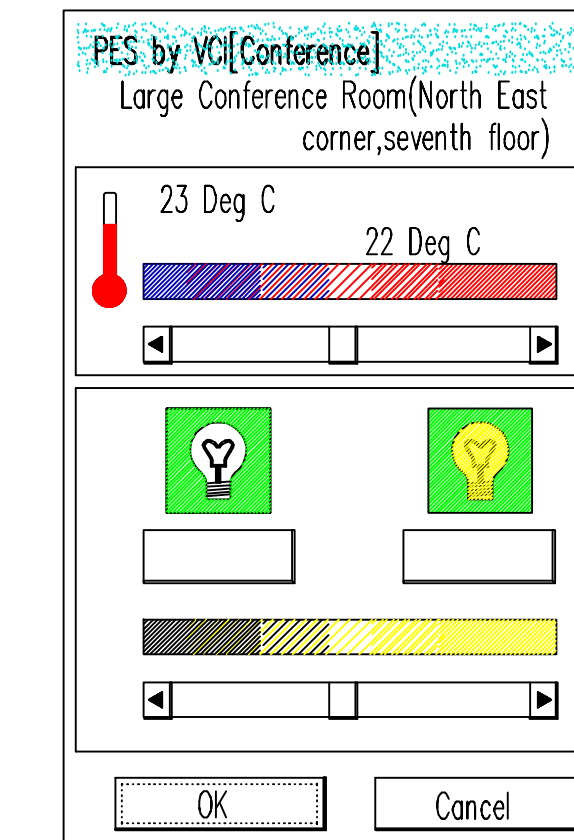

PERSONAL ENVIRONMENTAL SYSTEM USER INTERFACE APPLICATION

THE PERSONAL ENVIRONMENTAL SYSTEM (PES), IS AN INTEGRATED OFFICE SYSTEM DESIGNED TO PROVIDE INDIVIDUAL CONTROL OF TEMPERATURE AND LIGHTING IN USER'S PERSONAL WORK AREA.

LEGEND

- ENCLOSURE E17 SMART CONTROL
- PERSONAL ENVIRONMENTAL SYSTEM APPLICATION [PES]
- EXISTING OR OWNER SUPPLIED P.C.
- JOINER CABLE 102-347-JCS
- JOINER CABLE 31MFbk16a
- BALLAST CABLE 79MFbk12a (7 cond.#18 str.)
- CONTROL CABLE 50RSPX24A
- JOINER CABLE TO NEXT BOX ON SAME CIRCUIT
- LOW VOLTAGE SWITCH
- OCCUPANCY SENSOR CLG. MTD.
- AMBIENT LIGHT SENSOR
- RECEPTACLE BOX BX-Y-Z c/w number/type of rtr'ts (to suit)
- FEEDER STARTER _C #12+grd "ULTRALX-105 deg. (_C=# of conductors to suit)
- FEEDER _C #12+grd "ULTRALX-105 deg. (_C=# of conductors to suit)
- LOCKNUTLESS BOX CONNECTOR
- FLUORESCENT FIXTURE 2x4
- SMART CONTROL NETWORK CABLE
- PERSONAL AIR DELIVERY
- USER NETWORK CABLE
- SINGLE RECEPTACLE STYLE 79R
- MALE CORD CAP STYLE 79M
- FEMALE CORD CAP STYLE 79F
- SINGLE PLUG STYLE 79P
- CONTROL DAMPER AND ACTUATOR
- MICRO-TOUCH TEMPERATURE DEVICE
- 2 gang NOCOM pre-assembly [devices/moulded cables as required]
- 4 gang NOCOM pre-assembly [devices/moulded cables as required]
- 6 gang NOCOM pre-assembly [devices/moulded cables as required]
- ULTRALX CABLE [available 1/2", 3/4" or 1"] TO CABLE TRAY or TELEPHONE ROOM
- 41MT [PH,N,I,G.&GRD]moulded plug[available 31MT[PH,N&GRD.]42MT[2PH,N.&GRD.]
- 92MT [3PH,3N,2ig.&grd]moulded plug , pre-assembled to screen by furniture manufacturer
- FURNITURE SCREEN

ISSUE REVISION DATE

ISSUED FOR INFORMATION ONLY, AND TO CONVEY THE GENERAL INTENT OF THE LAYOUT AND INSTALLATION OF NOCOM MODULAR WIRING SYSTEM SHOWN.
DO NOT SCALE DRAWING.
DIAGRAMMATIC-FIELD COORDINATE

OWNERSHIP OF DOCUMENTS:
THIS DRAWING AND ACCOMPANYING INFORMATION ARE THE PROPERTY OF NOCOM. NO REPRODUCTION OR USE IN WHOLE OR IN PART BY ANY FORM WHETHER THE WORK FOR WHICH THEY ARE PRESENTED BE EXECUTED OR NOT IS PERMITTED WITHOUT THE EXPRESS WRITTEN PERMISSION OF NOCOM.

NOCOM
105 Willowlea Road, Corp, Ont, Canada K0A-1L0
Telephone (613)831-8102 Fax (613)831-8103
Toll Free 1-888-725-7438 E-Mail info@nocom.ca

PROJECT TITLE
APPLICATION
OVERVIEW LAYOUT

DRAWN BY: TJP
CHECK BY: TJP
DATE: 2000

PROJ: 00-000
REV: 04
SCALE: N.T.S.